


**ANZONERI
DEVELOPMENT
GROUP INC.**

248A Scherer Boulevard
Franklin Square, New York 11010
516.502.4585
info@anzoneri.com

108-18 Queens Blvd., Suite 1A
Forest Hills, NY 11375
tel. 718.268.0988
fax. 718.268.0989
t.e. project no. V100034
www.tanengineering.com

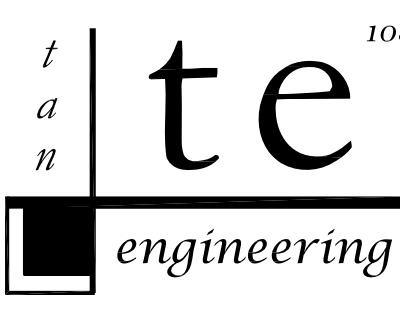

PROJECT:
**New Crumbs Bakeshop @
2838 N Clarendon Blvd.
Arlington, Virginia 22201**



CLIENT:
Crumbs Bakeshop
110 West 40th Street
Suite 310
New York, New York 10018

ISSUES:
No. Date Description
1 06/23/10 ISSUED FOR BID
2 06/23/10 ISSUED FOR BID

SEAL:
DRAWN BY:
RT

SCALE:
As Noted

DRAWING TITLE:
First Floor Electrical Lighting
& Power Plans and Elevation
DRAWING NO.
E-201.00
SHEET 2 OF 3

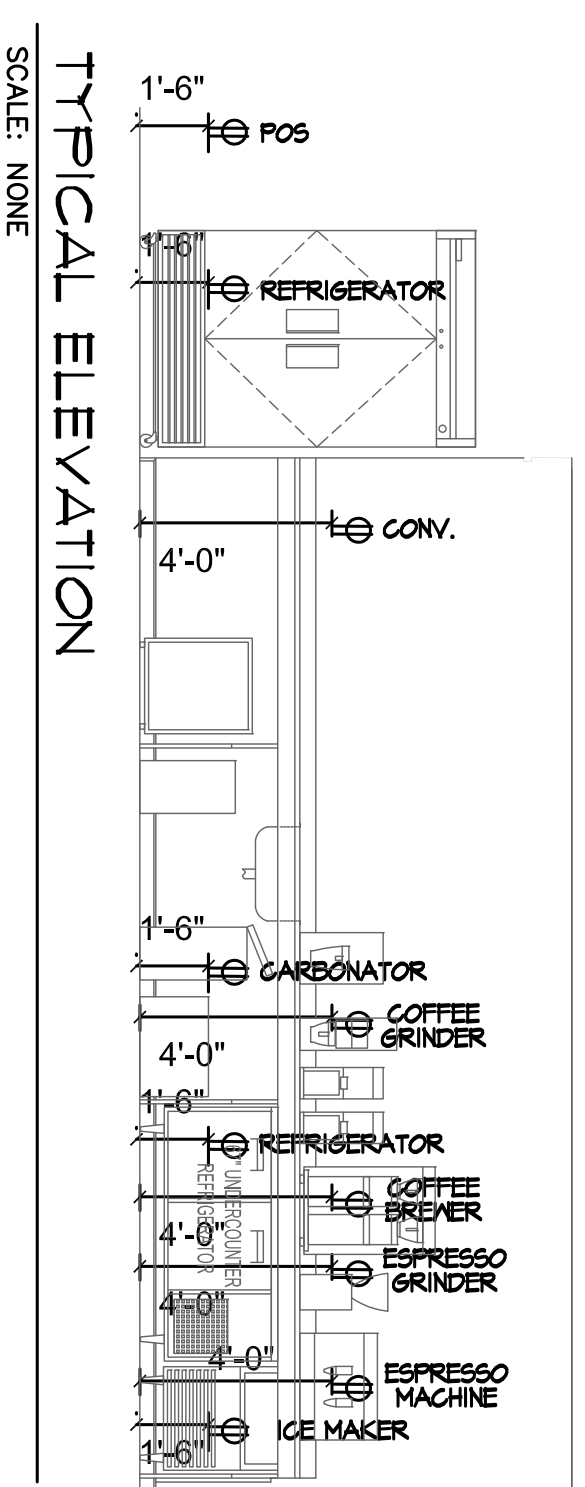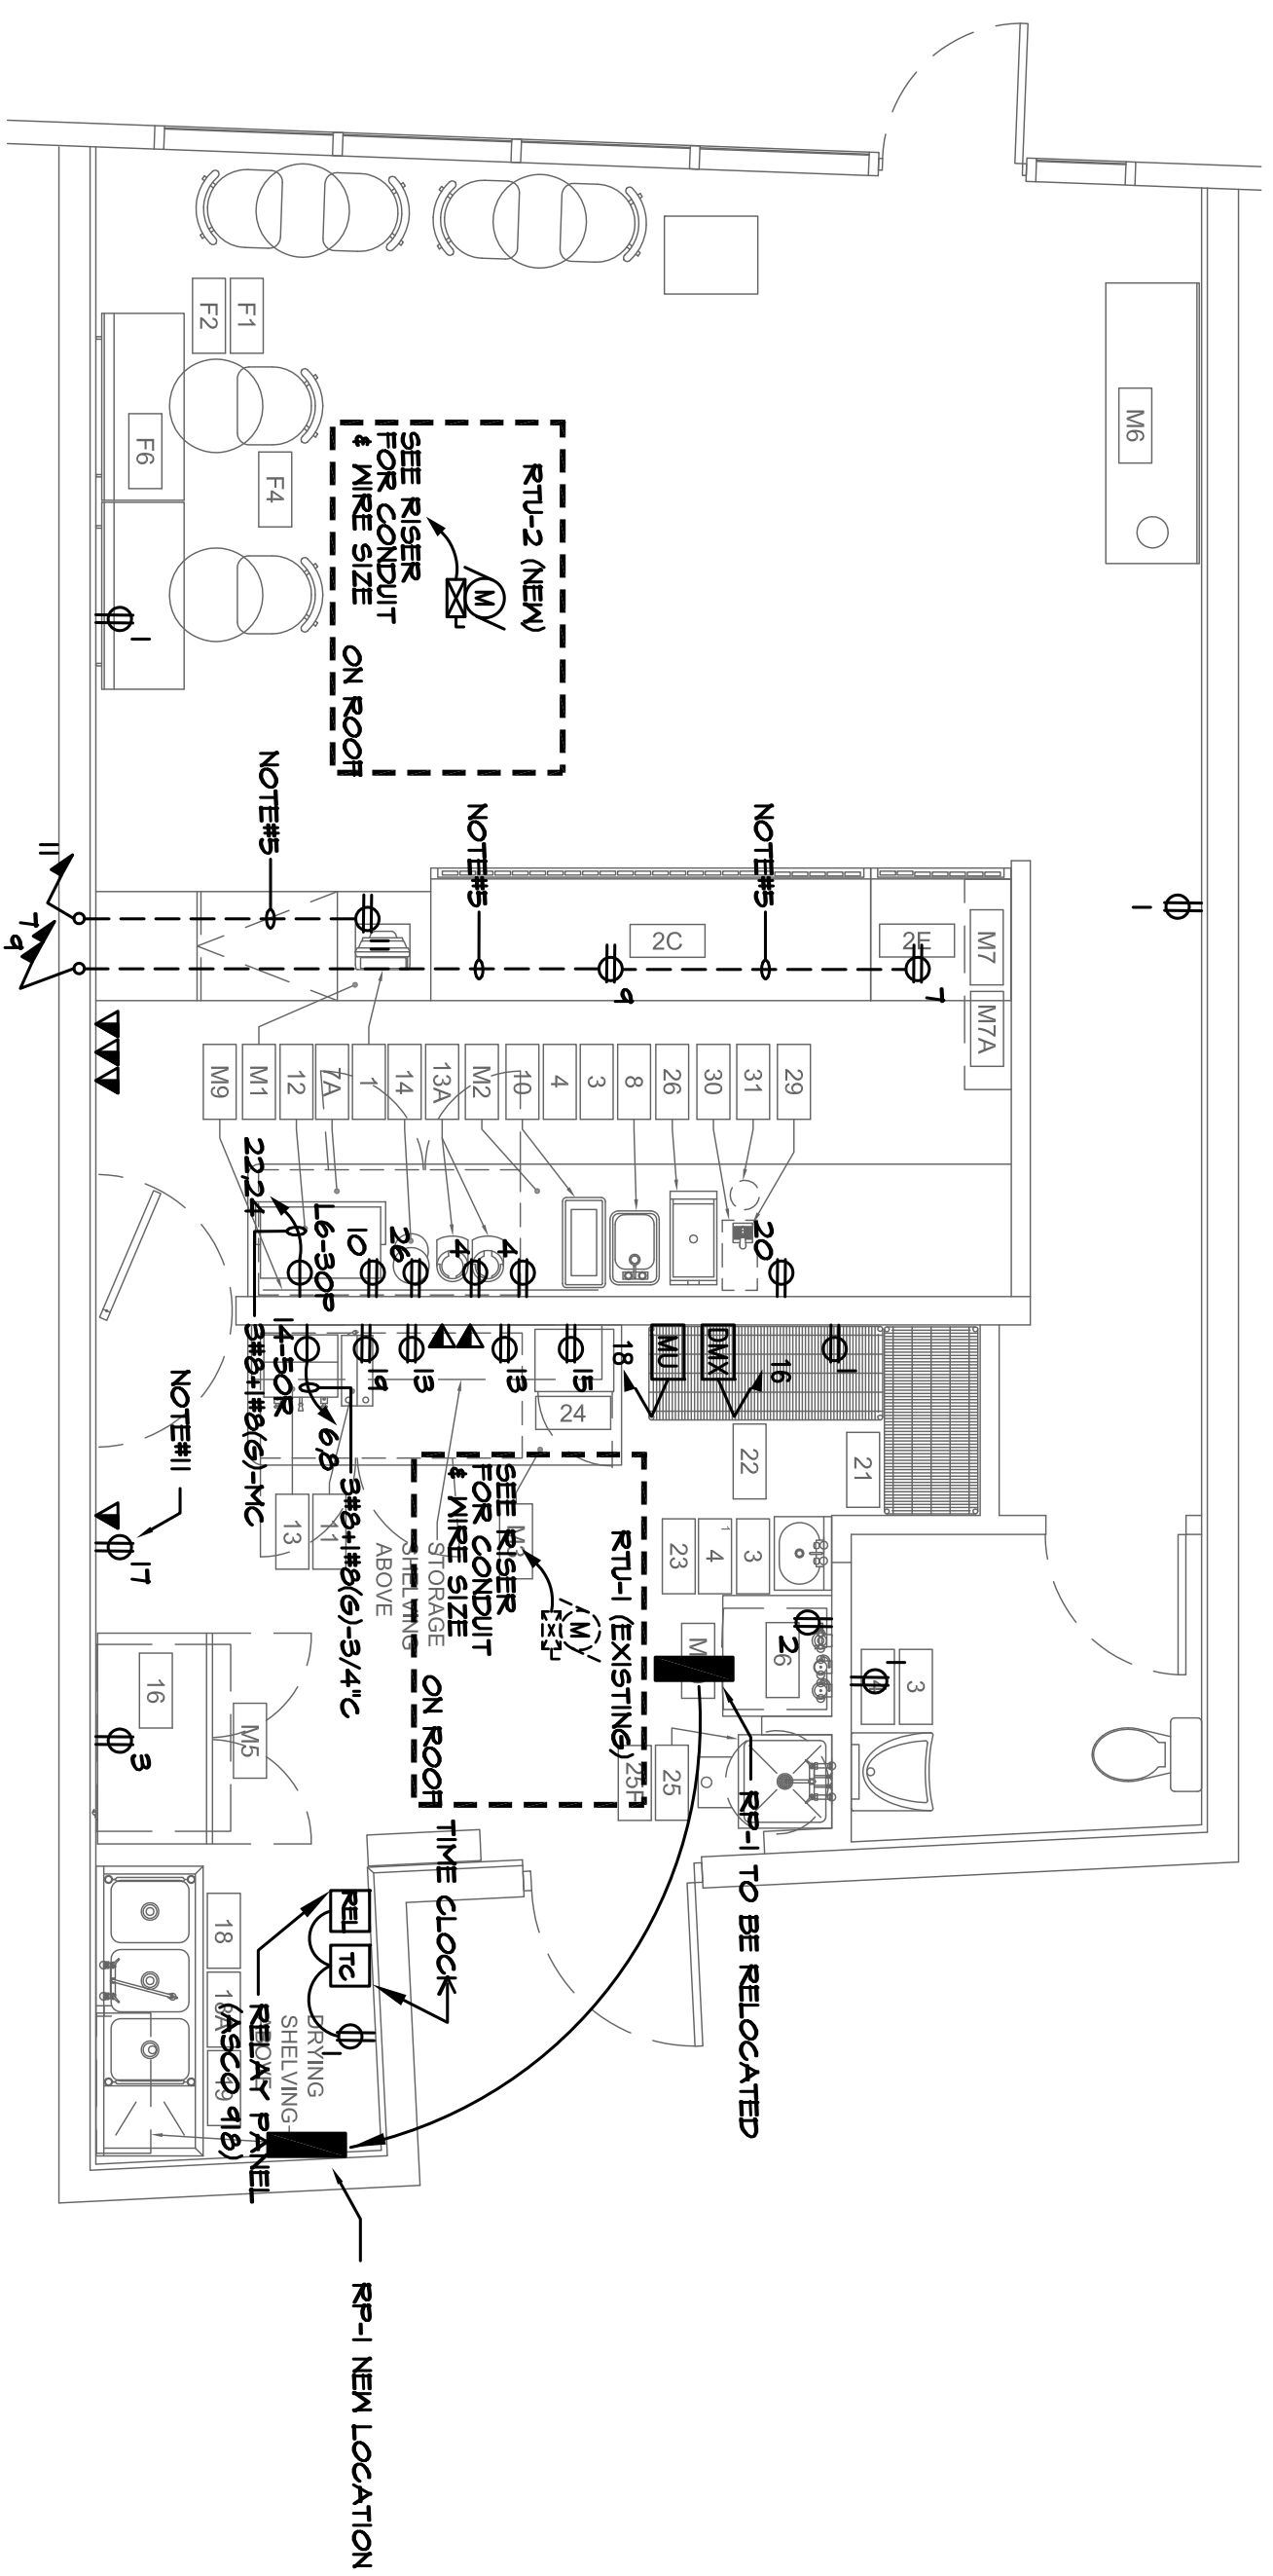

- POWER PLAN NOTES:**
1. CIRCUIT ALL DEVICES TO PANEL RP-1!
 2. COORDINATE EXACT LOCATION OF MECHANICAL EQUIPMENT WITH MECHANICAL CONTRACTOR
 3. REFER TO DRAWING E-1 FOR PANEL SCHEDULE
 4. ALL DUPLEX RECEPTACLES SHALL BE GFCI TYPE
 5. ROUTE ALL CIRCUITING WITHIN MILLWORK. COORDINATE ALL ROUTING IN FIELD.
 6. REFER TO DRAWING E-1 FOR MISC SYSTEM SCOPE
 7. ALL RECEPTACLES SHALL BE GFCI TYPE
 8. PROVIDE 1000 VA UPS TO POINT OF SALE STATION. LOCATE IN MILLWORK. COORDINATE IN FIELD.
 9. PROVIDE LOOP VA UPS TO DMX MISC SYSTEM. LOCATE IN MILLWORK. COORDINATE IN FIELD.
 10. ALL COVER PLATES SHALL BE WHITE IN COLOR UNLESS OTHERWISE SPECIFIED OR DIRECTED BY OWNER/ARCHITECT.
 11. PROVIDE RECEPTACLE WITH SURGE SUPPRESSION FOR EMPLOYEE TIME CLOCK
 12. SIMILAR TO LEVITON MODEL 5960.

LIGHTING SCHEDULE

MARK	DESCRIPTION	MANUF.	MODEL	REMARKS
LT-1	HANGING PENDANT - 18"	REJUVENATION	JEFFERSON # AA 5972	SUPPLIED BY OWNER
LT-2	REJUVENATION	ROSE CITY # AA 5348		SUPPLIED BY OWNER - 24" FIXTURE LENGTH
LT-3	RECESSED LAV-IN FLOOR - 24" X 24"	LAMAR LIGHTING	LS1722ER1PA	
LT-4	RECESSED LAV-IN FLOOR - 24" X 48"	LAMAR LIGHTING	LS4324ER1PA	
LT-5	SURFACE MTD FLOOR - 24" X 24"	LAMAR LIGHTING	SB41722ER1PA	
LT-6	SURFACE MTD FLOOR - 24" X 48"	LAMAR LIGHTING	SB4324ER1PA	
LT-7	RECESSED LAMP - DOWN LIGHT	LIGHTOLIER	1101F2642ICU	FIXTURE w/1101HCD DOWNLIGHT REFLECTOR - 28W COMPACT FLUOR LAMP
LT-8	RECESSED LAMP - WALL WASHER	LIGHTOLIER	1101F2642ICU	FIXTURE w/1101HCD DOWNLIGHT REFLECTOR - 28W COMPACT FLUOR
LT-9	EXIT LIGHT W/EMERGENCY LIGHT COMBO	ATLITE	PC3	
LT-20	EMERGENCY LIGHTING	ATLITE	PCI-10	

LIGHTING PLAN NOTES:

1. CIRCUIT ALL DEVICES TO PANEL RP-1!
2. COORDINATE EXACT LOCATION OF MECHANICAL EQUIPMENT WITH MECHANICAL CONTRACTOR
3. REFER TO DRAWING E-1 FOR PANEL SCHEDULE
4. CIRCUIT NUMBER 43 SHALL NEVER BE SWITCHED AND REMAIN ON ALWAYS.
5. FIXTURES WITH 'NL' DESIGNATION ARE NIGHT LIGHTING AND SHALL BE ON ALWAYS. NEVER SWITCHED.
6. ALL LIGHTING WITH EXCEPTION TO NIGHT LIGHTING SHALL BE CONTROLLED BY A LIGHTING RELAY PANEL.

ALTERNATE PRICING:

1. PROVIDE AN ADDITIONAL PRICE FOR EXTERIOR SIGN LIGHTING WITH TIME CLOCK

