


**CANZONE**  
**DEVELOPMENT**  
**GROUP INC.**

248A Scherer Boulevard  
Franklin Square, New York 11010  
516.502.4585  
info@canzoneit.com

108-18 Queens Blvd., Suite 1A  
Forest Hills, NY 11375  
tel. 718.268.0988  
fax. 718.268.0989  
t.e. project no. Y100034  
www.tanengineering.com

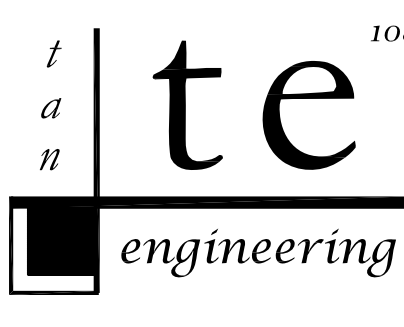

**PROJECT:**

**New Crumbs Bakeshop @**  
2838 N Clarendon Blvd.  
Arlington, Virginia 22201

**CLIENT:**

Crumbs Bakeshop  
110 West 40th Street  
Suite 310  
New York, New York 10018

**ISSUES:**

No.	Date	Description
1	06/23/10	ISSUED FOR BID

**SEAL:**

**DRAWN BY:**  
RT

**SCALE:**  
As Noted


**DRAWING TITLE:**  
Ground Floor HVAC Plans

**DRAWING NO.:**


**M-201.00**

**SHEET 2 OF 4**

**DEMOLITION**

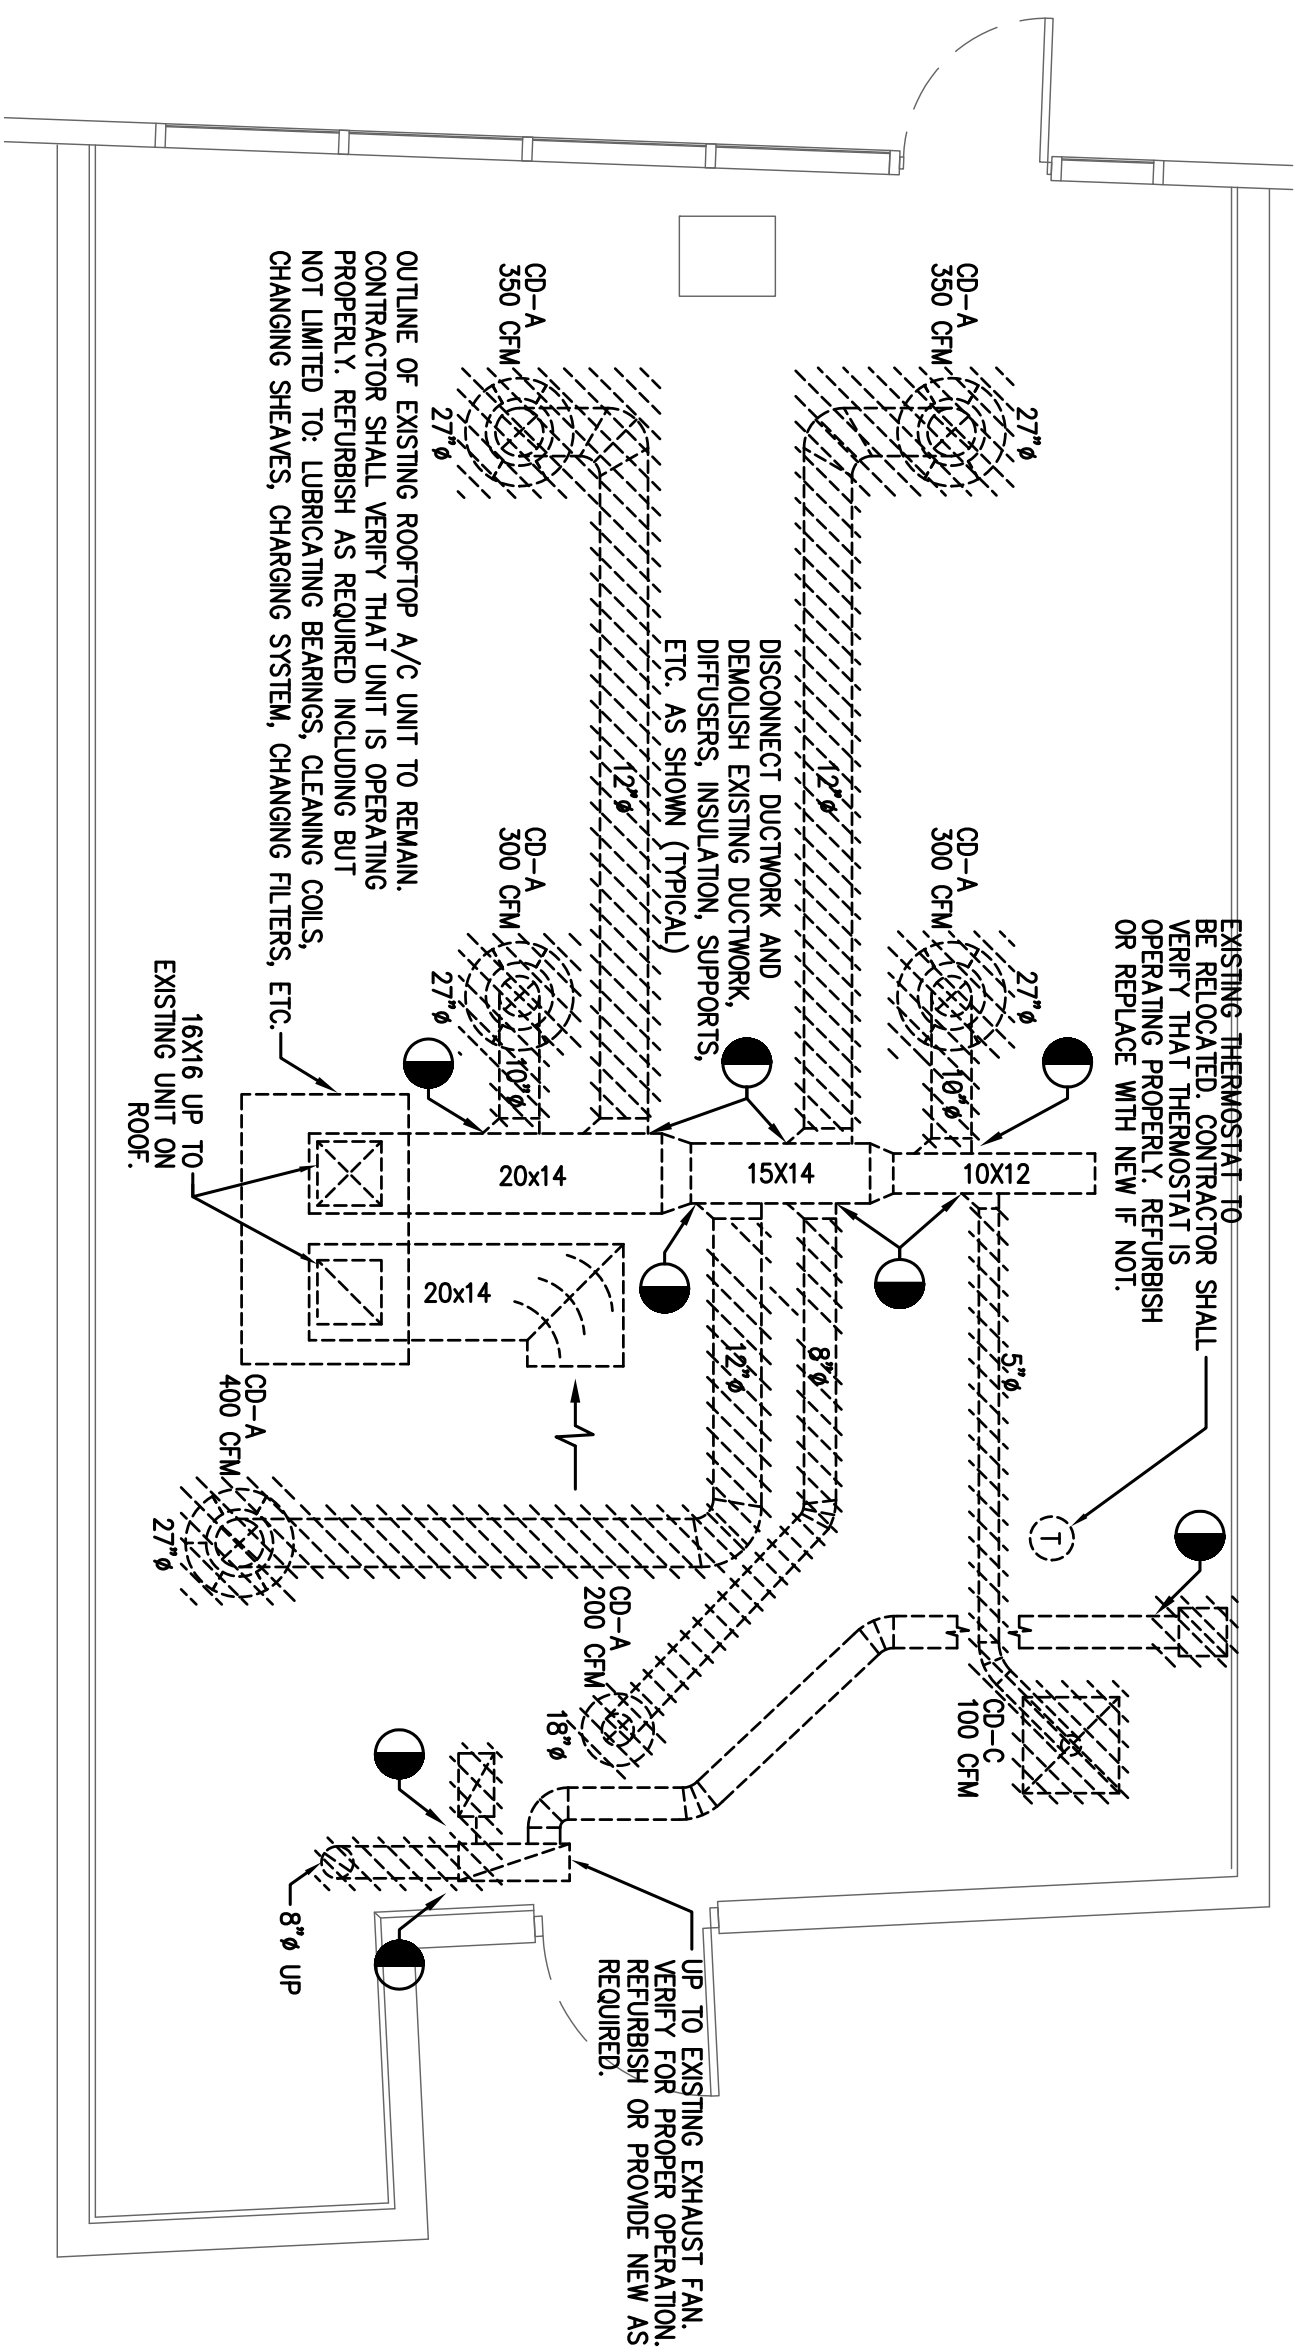

**1** First Floor HVAC Demolition Plan  
SCALE: 1/4" = 1'-0"

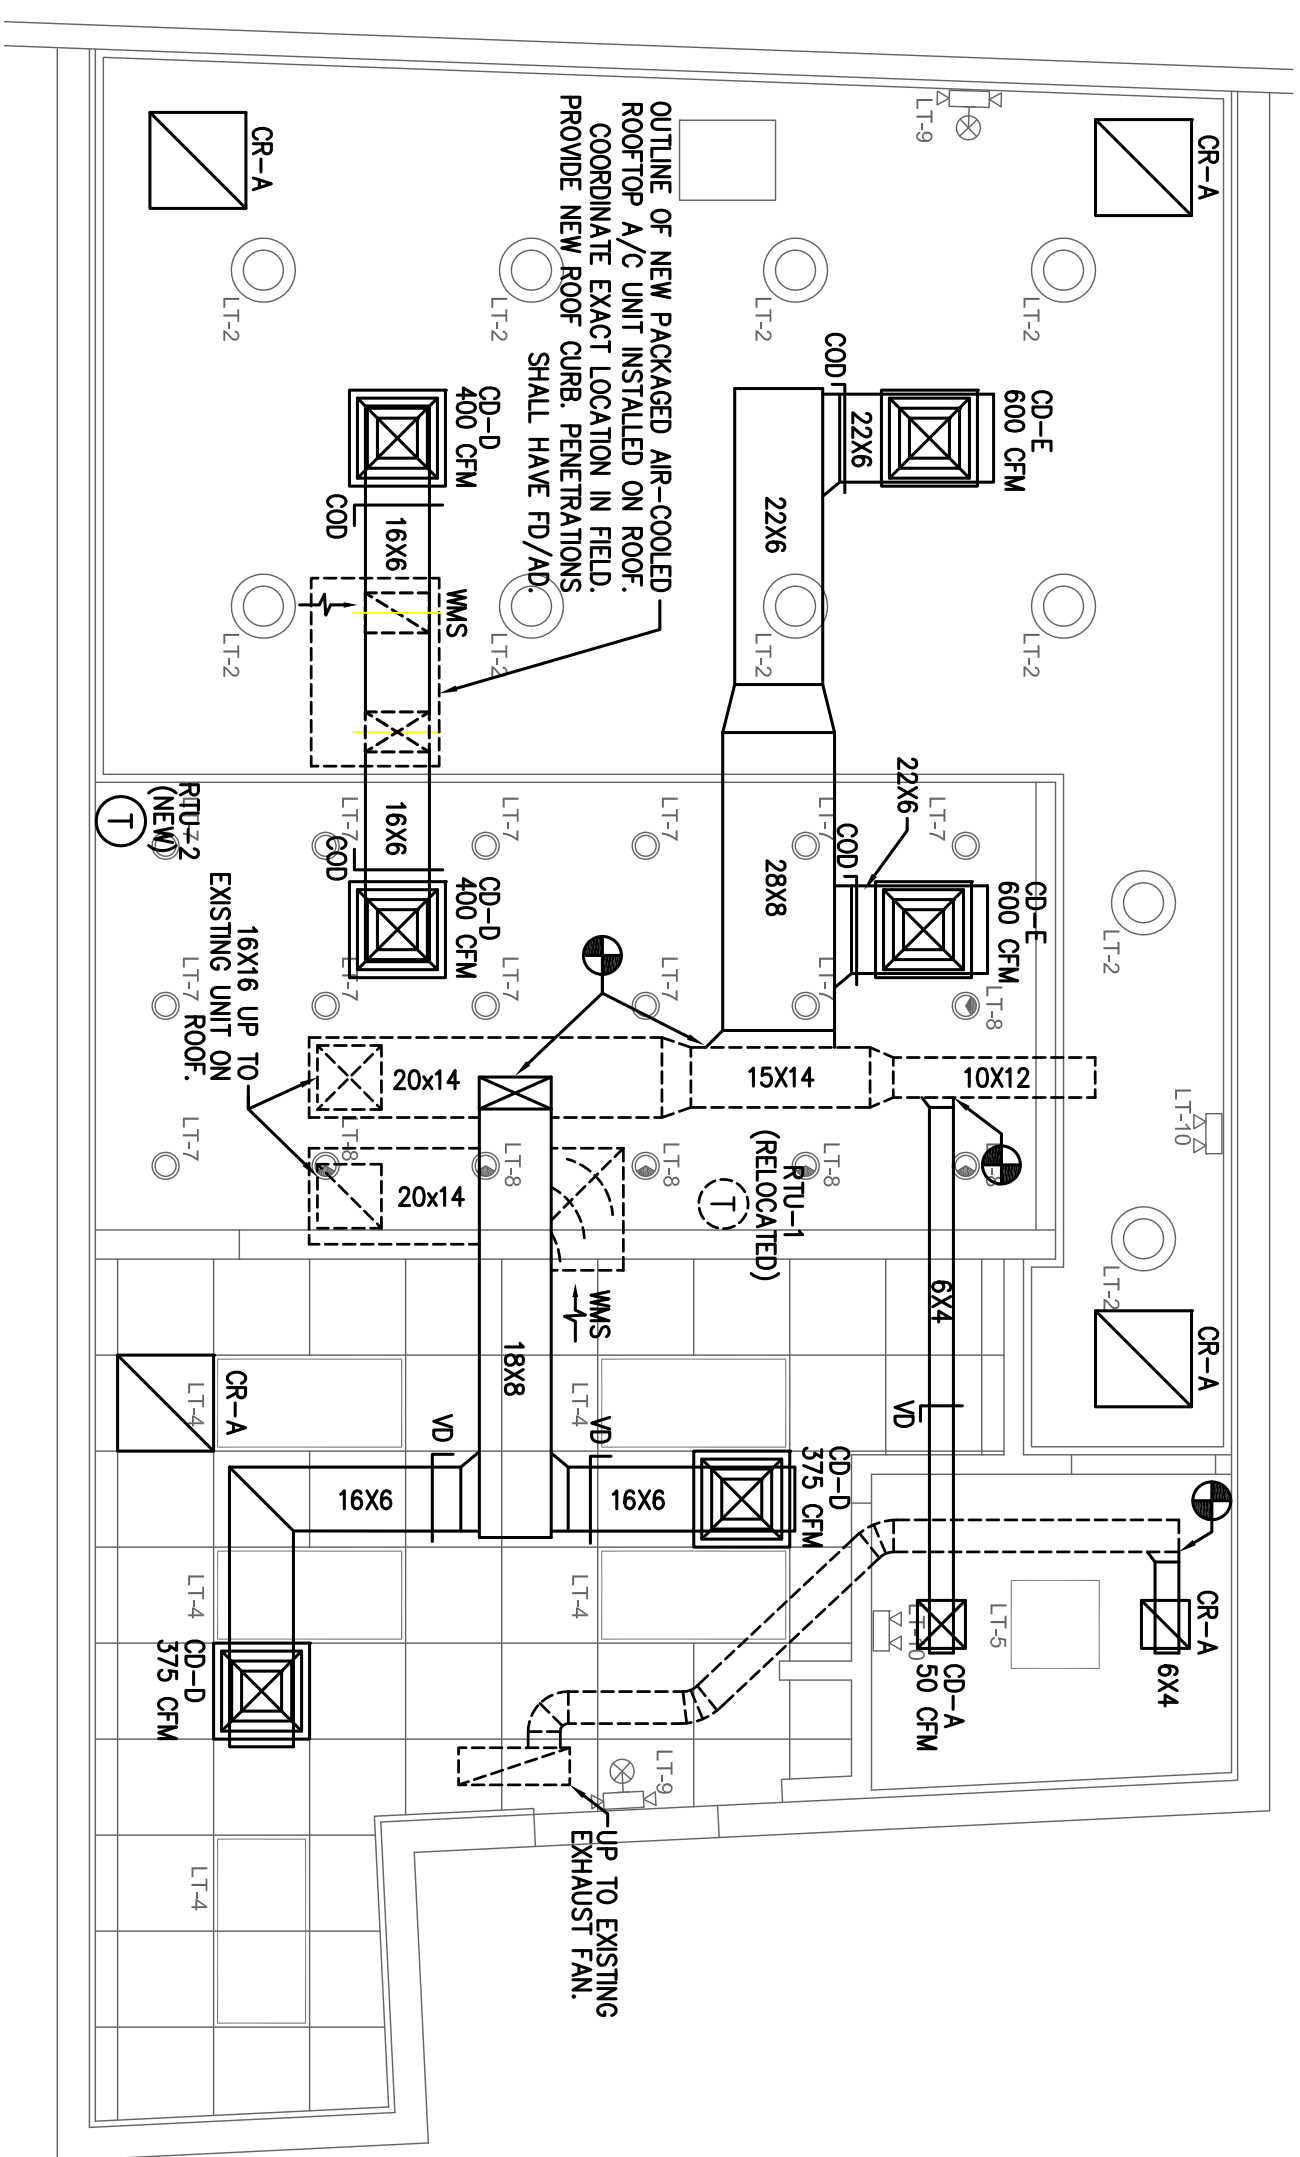

**2** First Floor HVAC Installation Plan  
SCALE: 1/4" = 1'-0"