


A

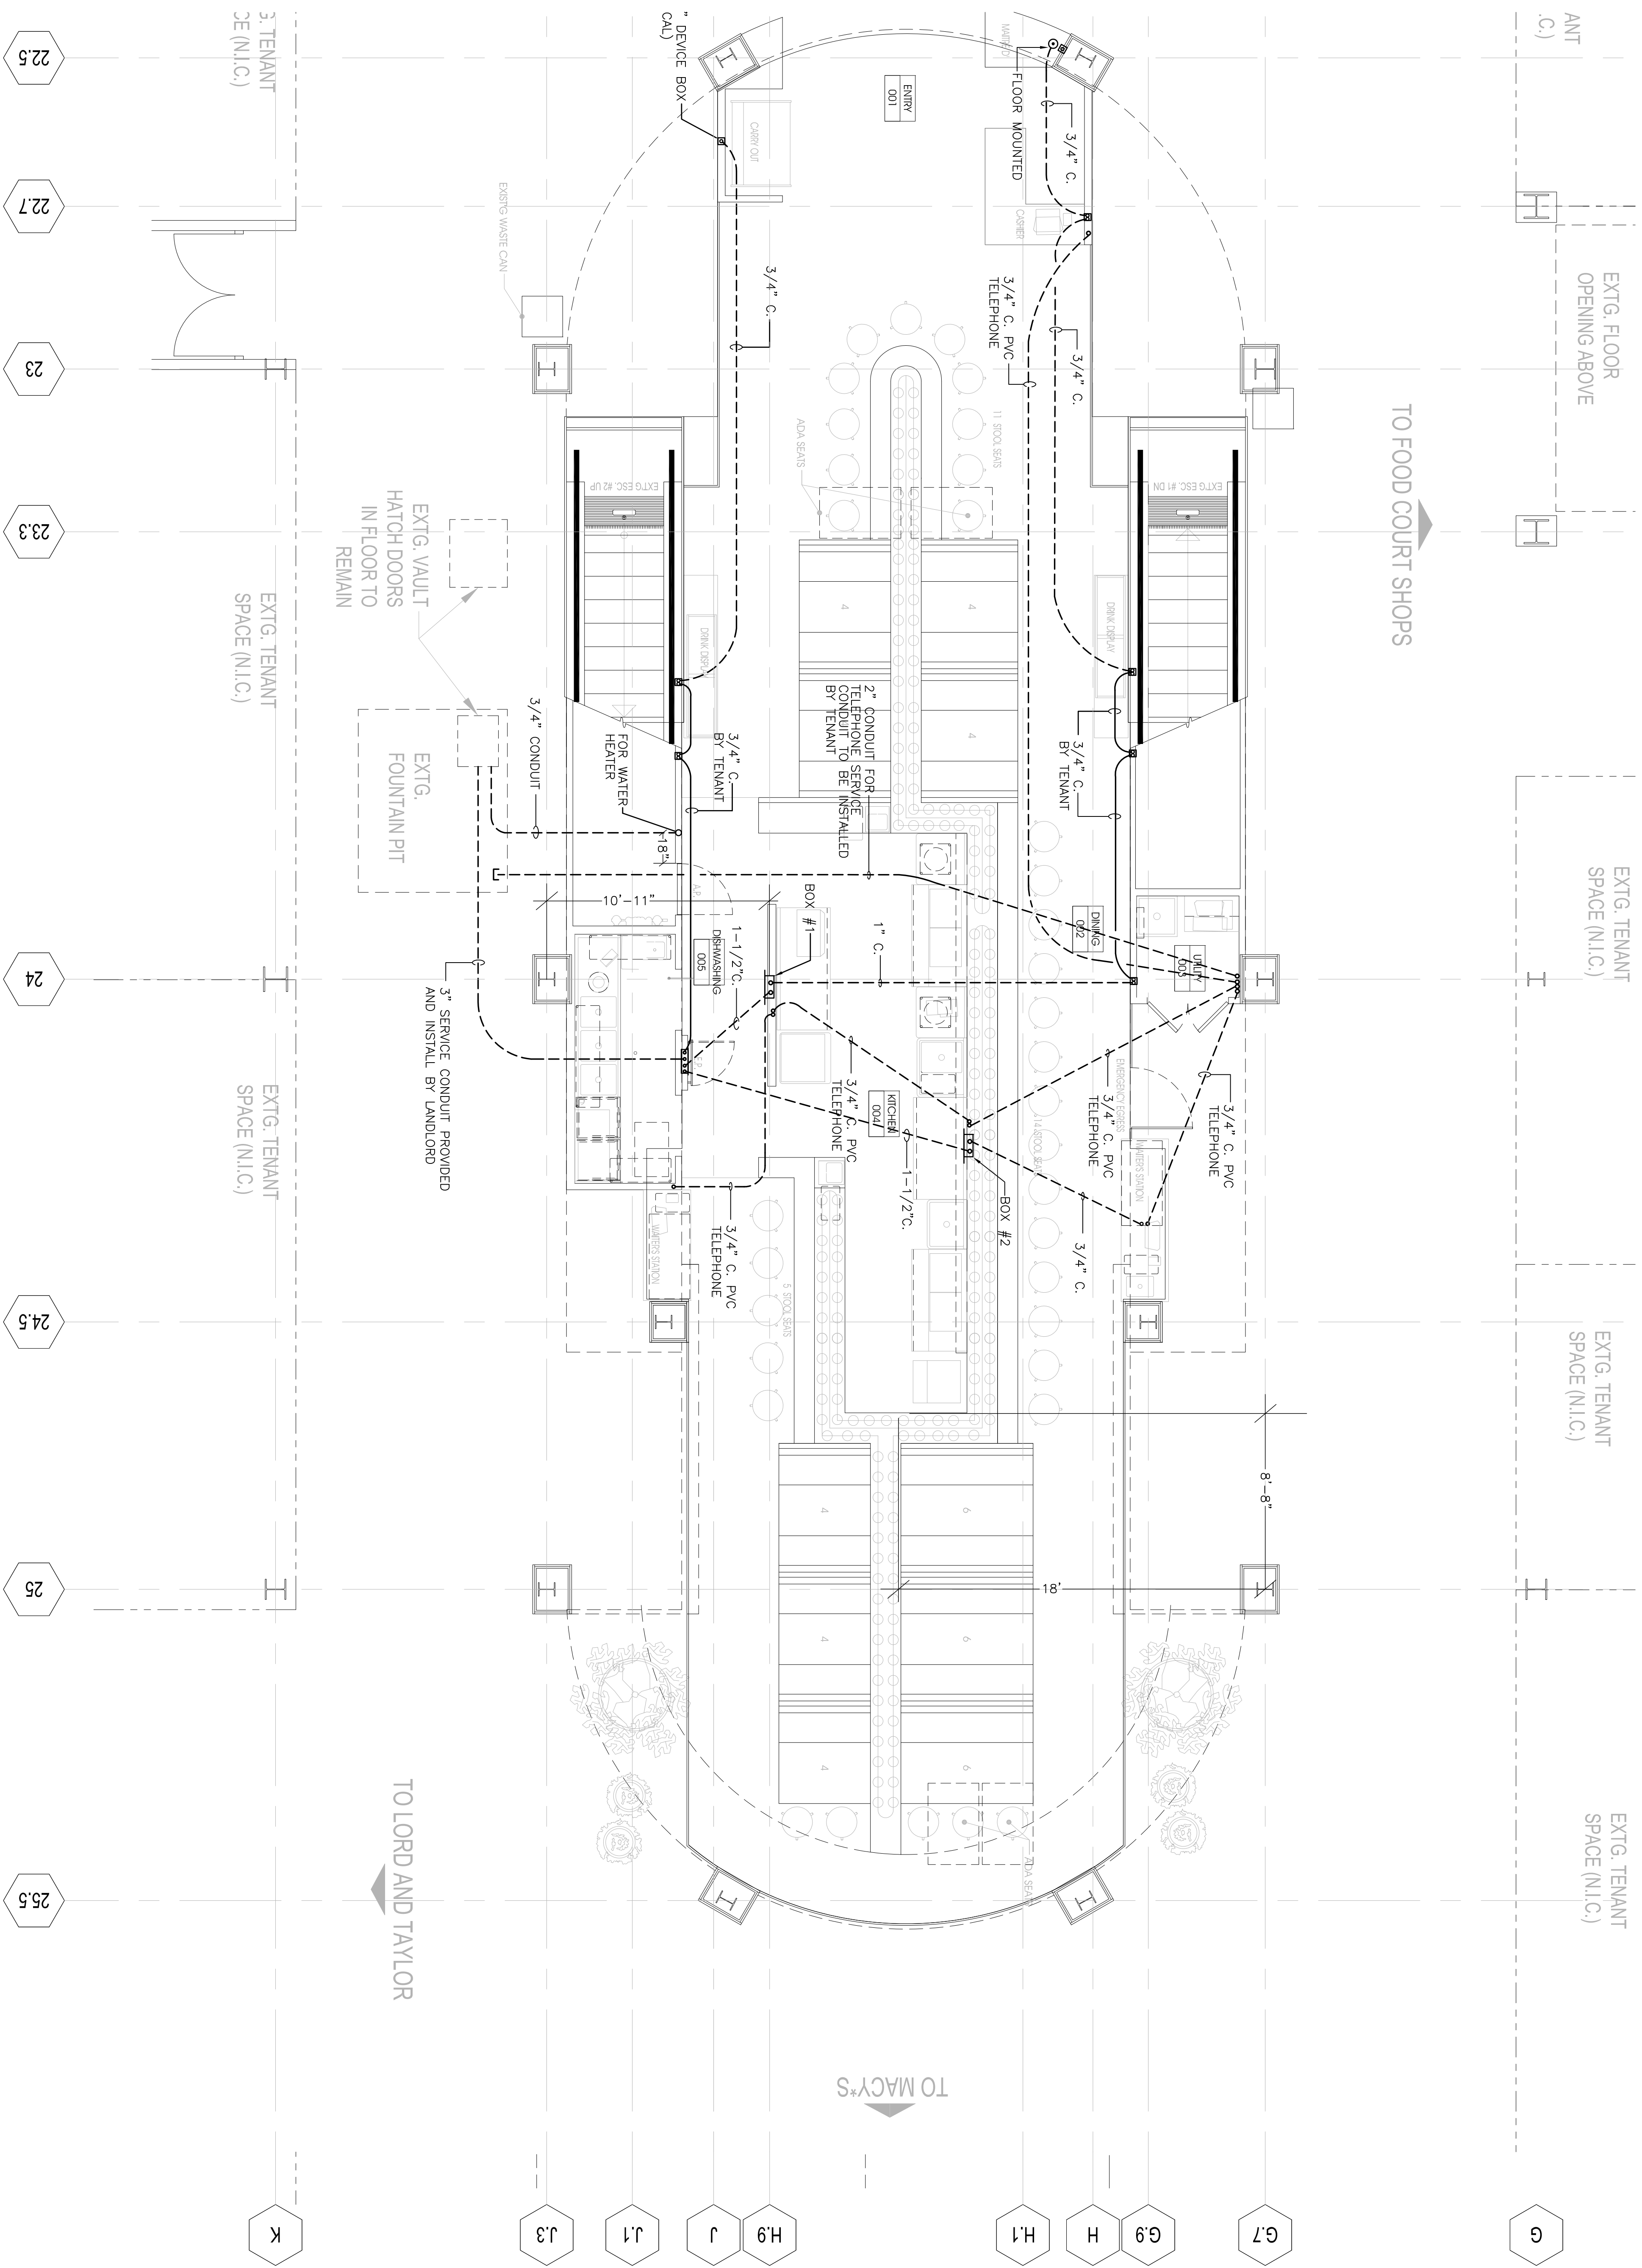

ELECTRICAL FLOOR PLAN-UNDER GROUND CONDUIT
SCALE: 1/4"=1'-0"

RUST | ORLING

1215 CAMERON STREET
ALEXANDRIA, VA
22314

V - 703.834.3205
F - 703.548.4779
odr@rustorling.com
www.rustorling.com

**WASABI
TYSONS
CORNER**

BANSAL
Mechanical Plumbing Electrical Engineers
Bansal & Associates, Inc.
50 South Piedmont Street
Suite 116
Alexandria, Virginia 22304
(703) 823-6694
Project Number: 2815300

08.054

REVISIONS

DATE	DESCRIPTION

FOR REVIEW
3.12.09

FLOOR PLAN

SHEET NO.

E1.2