



- REFERENCE NOTES**
- ① TO DESIGNATED PANEL VIA BOX #2
  - ② TO DESIGNATED PANEL VIA BOX #1
  - ③ 3 #8 + 1 #10 G IN 3/4" CONDUIT.
  - ④ NOT USED.
  - ⑤ RECEPTACLE MOUNTED IN THE MILLWORK

EQUIPMENT SCHEDULE	
⑤	RICE COOKER
⑥	MAKI ROBOT
⑦	REFRIGERATED PREP TABLE, SUSHI
⑧	SUSHI ROBOT
⑬	REFRIGERATED PREP TABLE, DESERT
⑭	WORKTOP REFRIGERATOR
⑮	ICE MAKER
⑰	WORKTOP REFRIGERATOR, HOT FOOD
⑳	INDUCTION WARMER
㉑	CONVENTION MICROWAVE OVEN
㉒	BREWAGES REFRIGERATOR
㉓	P.O.S. TERMINAL
㉔	DISPOSER AND CONTROL
㉕	UNDER COUNTER WAREWASHER
㉖	CARRIOUT REFRIGERATOR

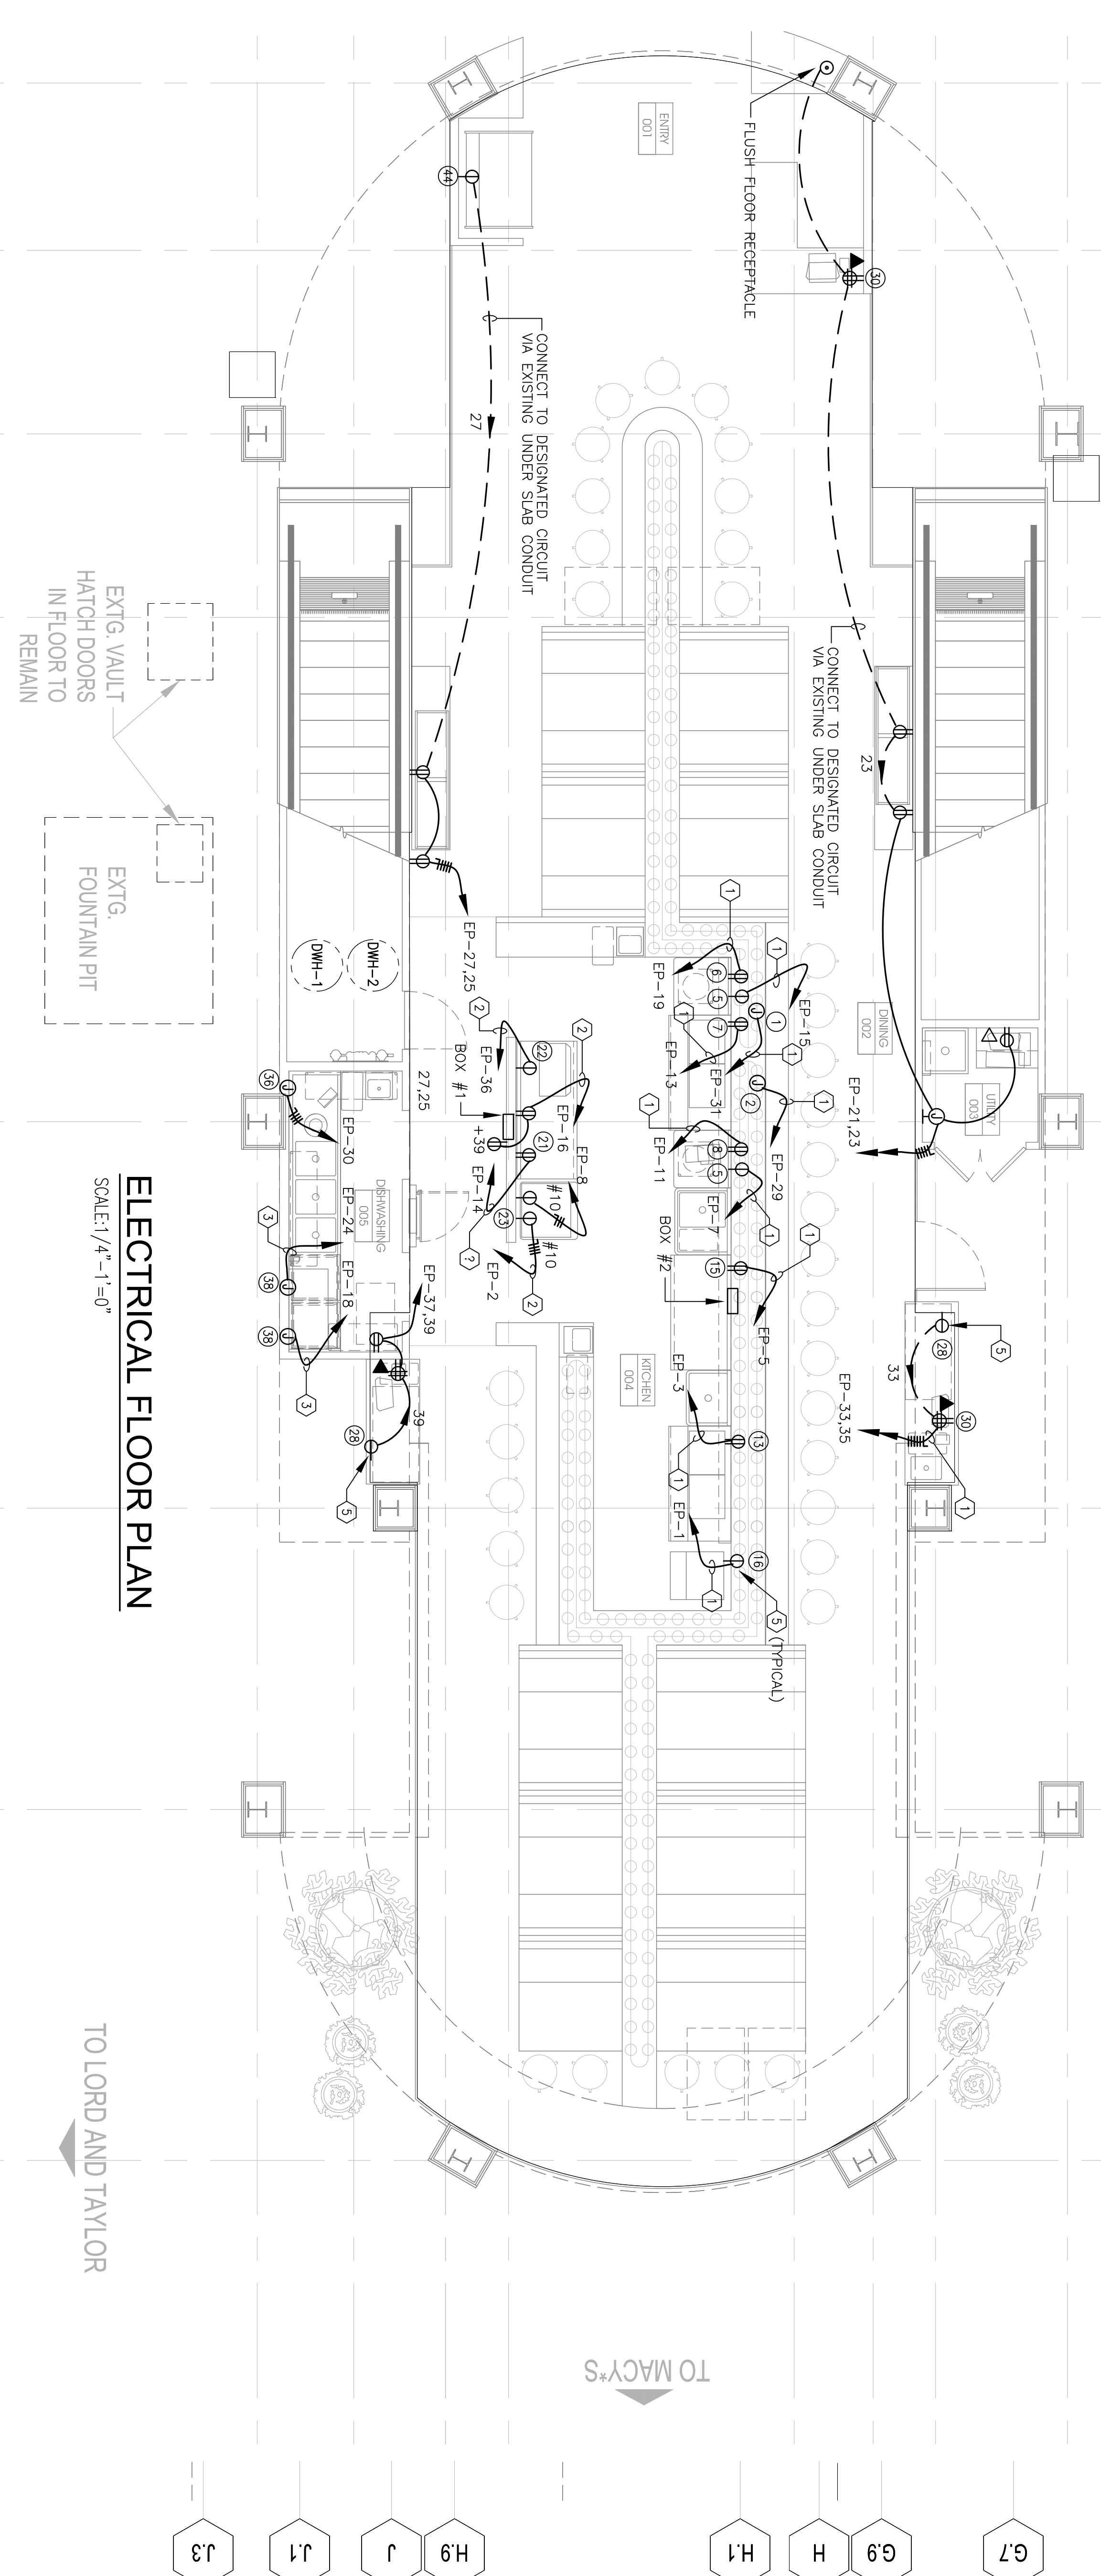

**ELECTRICAL FLOOR PLAN**  
 SCALE: 1/4" = 1'-0"

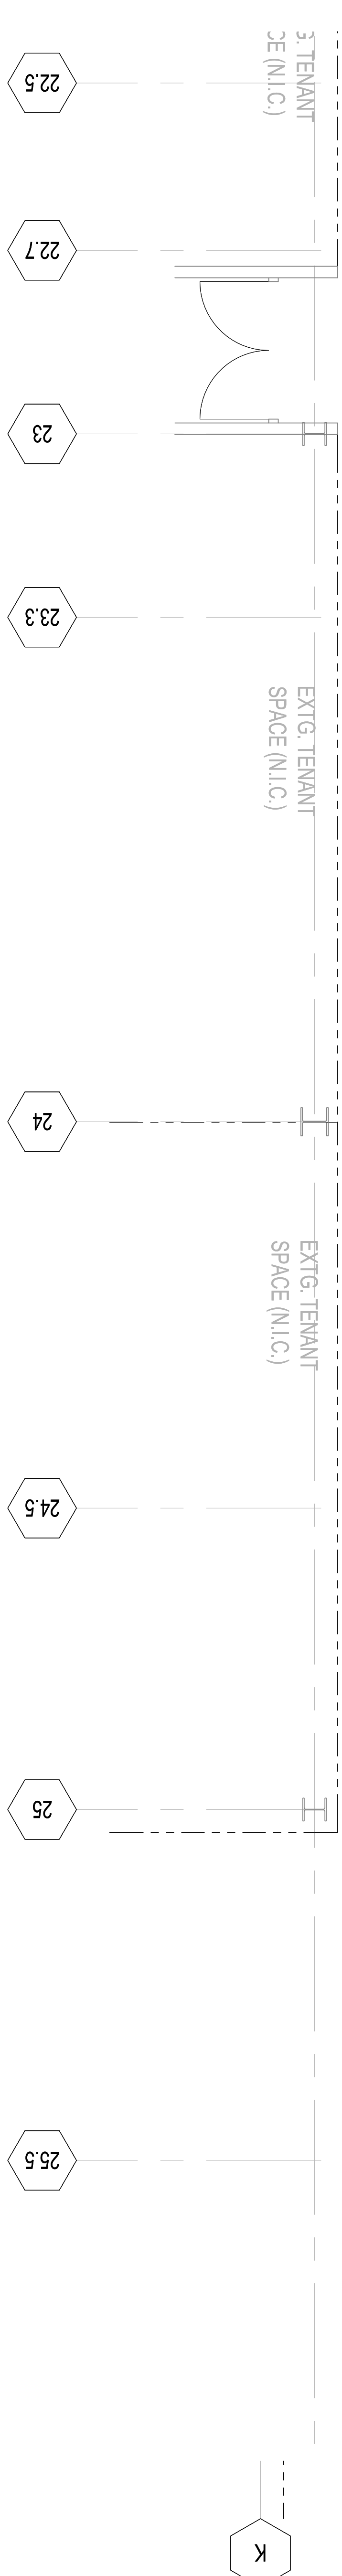

A

G.7, H.1, H.9, J.1, J.3, K

**RUST | ORLING**  
 1215 CAMERON STREET  
 ALEXANDRIA, VA  
 22314  
 V - 703.834.3205  
 F - 703.548.4779  
 odr@rustorling.com  
 www.rustorling.com

**WASABI  
 TYSONS  
 CORNER**

**BANSAL**  
 Mechanical Plumbing Electrical Engineers  
 Bansal & Associates, Inc.  
 50 South Piedmont Street  
 Suite 116  
 Alexandria, Virginia 22304  
 (703) 823-6694  
 Project Number: 2815300

08.054

DATE	DESCRIPTION

FOR REVIEW  
 3.12.09

FLOOR PLAN

SHEET NO.

**E1.3**