


PLUMBING PLAN - SANITARY
1/4"=1'-0"

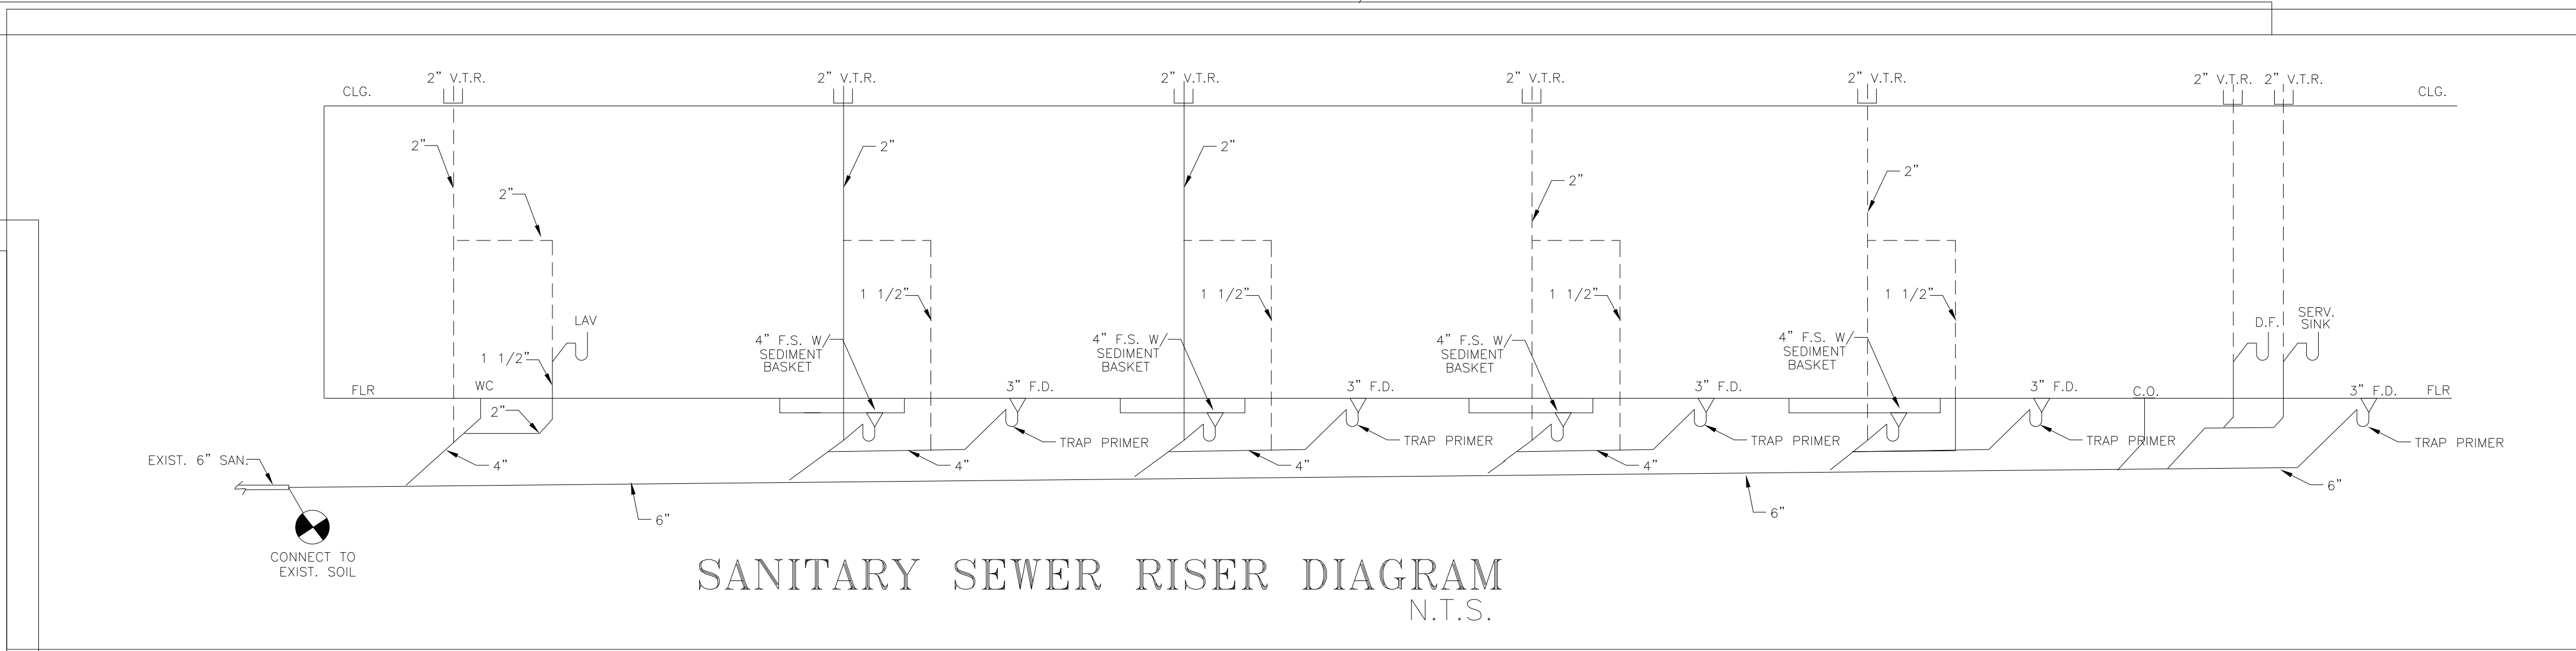

SANITARY SEWER RISER DIAGRAM
N.T.S.

PLUMBING LEGEND		
SYMBOL	ABBREV.	DESCRIPTION
---	CW	COLD WATER, DOMESTIC
---	HW	HOT WATER, DOMESTIC
---	HW/R	HOT WATER RECIRC., DOMESTIC
---	G	GAS
---	SAN	SANITARY
---	V	SANITARY VENT
---	D	(A/D) CONDENSATE DRAIN
---	CD	CLEANOUT, LINE, FLOOR
---	D	DOOR LID/VEH
---	CL	CENTER LINE
---	UC	UNDERCUT
---	PRV	PRESSURE REDUCING VALVE
---		SOLENOID VALVE
---		2-WAY CONTROL VALVE
---		2-WAY CONTROL VALVE
---		GAS COCK
---		RELIEF VALVE (TYPE AS NOTED)
---		TERMAL EXPANSION VALVE
---	FF	FLOW FITTING (ORIFICE TYPE), GPM NOTED
---	FF	FLOW FITTING (SELF-ADJUSTING), GPM NOTED
---	TR	THERMOSTAT, 'G' FOR GUARD, 'N' FOR NIGHT
---		BACKFLOW PREVENTER, DIRECTION OF FLOW INDICATED
---		PIPE GUIDE
---		PIPE ANCHOR
---		PIPE UNION
---		THERMOMETER
---		PRESSURE/TEMPERATURE TEST PLUG
---		PRESSURE GAUGE WITH STOPCOCK
---		GAUGE COCK
---		SHUT OFF VALVE (SEE SPECIFICATION FOR TYPE)
---		GLOBE VALVE
---		CHECK VALVE, DIRECTION OF FLOW INDICATED
---		BALANCING VALVE
---		DS & Y VALVE
---		BALL VALVE
---		BUTTERFLY VALVE
---	CX	CONNECT TO EXISTING

Issue Date:		
Revisions		
No.	Date	Description

LAUNDROMAT FIT-UP PLANS
8010 FENTON STREET
SILVER SPRING MD, 20910

Project Number: _____ Drawn By: _____
 Designed By: _____ Checked By: _____
 Sheet Title: **PLUMBING PLAN SANITARY**
 Sheet Number: **P-2**

ARCHITECTS
RAOUL LISSABET, A.I.A.
ARCHITECTS, LLC
 19021 SEDLEY TERRACE
 GAITHERSBURG, MARYLAND 20879
 Tel: (301) 948-3197 / Fax: (301) 990-4169

GEORGE WORSLEY P.E.
 7304 GEORGIA AVE., N.W.
 WASHINGTON, D.C., 20012
 TEL.: (202) 291-1666