


PLUMBING PLAN - SANITARY
1/4"=1'-0"

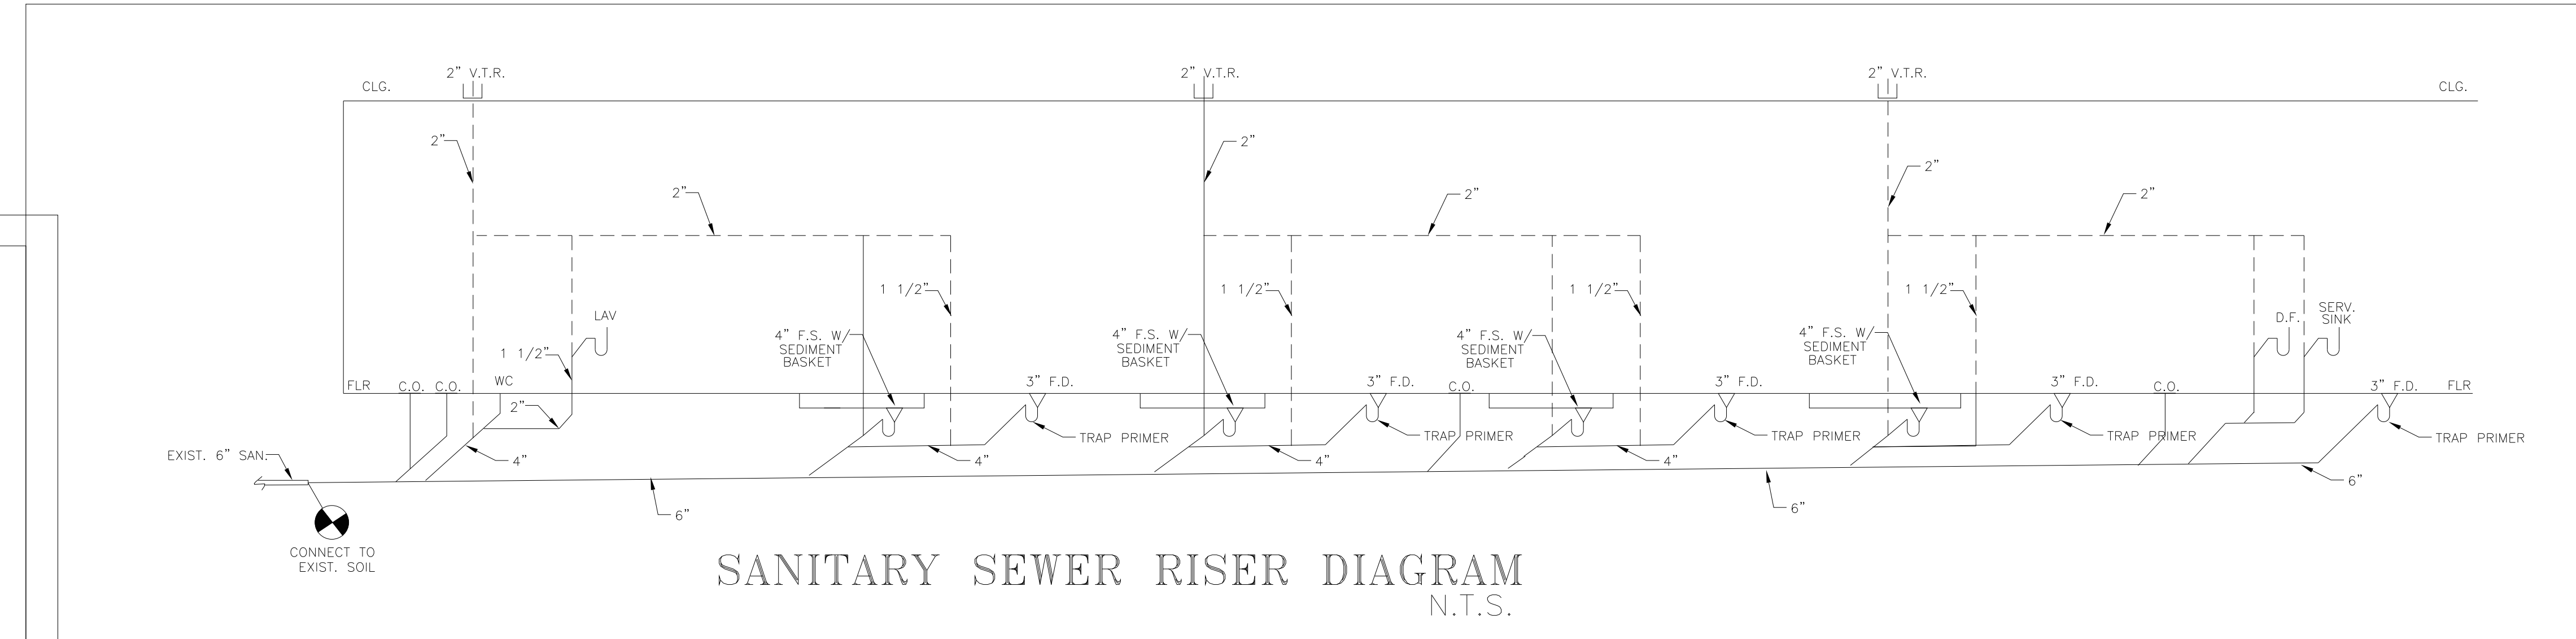

SANITARY SEWER RISER DIAGRAM
N.T.S.

PLUMBING LEGEND

SYMBOL	ABBREV.	DESCRIPTION
---	CW	COLD WATER, DOMESTIC
---	HW	HOT WATER, DOMESTIC
---	HW/R	HOT WATER RECIRC., DOMESTIC
---	G	GAS
---	SAN	SANITARY
---	V	SANITARY VENT
---	D	(A/D) CONDENSATE DRAIN
---	CD	CLEANOUT LINE; FLOOR
---	DL	DOOR LIDDER
---	CL	CENTER LINE
---	UC	UNDERCUTG
---	PRV	PRESSURE REDUCING VALVE
---	S	SOLENOID VALVE
---	2-WAY	2-WAY CONTROL VALVE
---	2-WAY	2-WAY CONTROL VALVE
---	GAS	GAS COCK
---	R	RELIEF VALVE (TYPE AS NOTED)
---	TE	TERMAL EXPANSION VALVE
---	FF	FLOW FITTING (ORIFICE TYPE); GPM NOTED
---	FF	FLOW FITTING (SELF-ADJUSTING); GPM NOTED
---	Th	THERMOSTAT; 'G' FOR GUARD, 'N' FOR NIGHT
---	B.P.	BACKFLOW PREVENTER; DIRECTION OF FLOW INDICATED
---	P	PIPE GUIDE
---	A	PIPE ANCHOR
---	U	PIPE UNION
---	Th	THERMOMETER
---	P.T.	PRESSURE /TEMPERATURE TEST PLUG
---	P.G.	PRESSURE GAUGE WITH STOPCOCK
---	G.C.	GAUGE COCK
---	S.O.V.	SHUT OFF VALVE (SEE SPECIFICATION FOR TYPE)
---	G.V.	GLOVE VALVE
---	C.V.	CHECK VALVE; DIRECTION OF FLOW INDICATED
---	B.V.	BALANCING VALVE
---	B.V.	BS & Y VALVE
---	B.V.	BALL VALVE
---	B.V.	BUTTERFLY VALVE
---	CX	CONNECT TO EXISTING

ARCHITECTS
RAOUL LISSABET, A.I.A.
ARCHITECTS, LLC
19021 SEDLEY TERRACE
GAITHERSBURG, MARYLAND 20879
Tel: (301) 948-3197 / Fax: (301) 990-4169

GEORGE WORSLEY P.E.
7304 GEORGIA AVE., N.W.
WASHINGTON, D.C., 20012
TEL.: (202) 291-1666

Issue Date:

Revisions		
No.	Date	Description

Permit Set
Oct. 15, 2009

TROPICANA LAUNDROMAT
LAUNDROMAT FIT-UP PLANS
8010 FENTON STREET
SILVER SPRING MD, 20910

Project Number:	Drawn By:
Designed By:	Checked By:
Sheet Title:	PLUMBING PLAN SANITARY
Sheet Number:	P-2